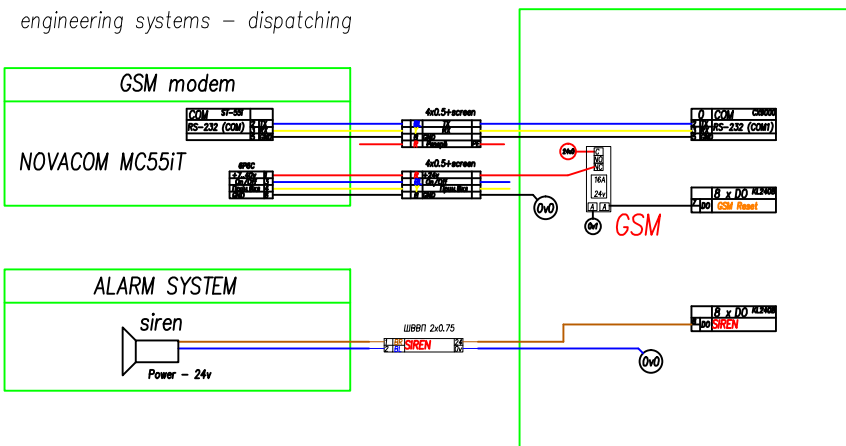


Изм.	Кол.	Лист	№ док.	Подпись	Дата							
						A Cottage (example)				Стадия	Лист	Листов
											1	
						Single-line diagram of the control panel						

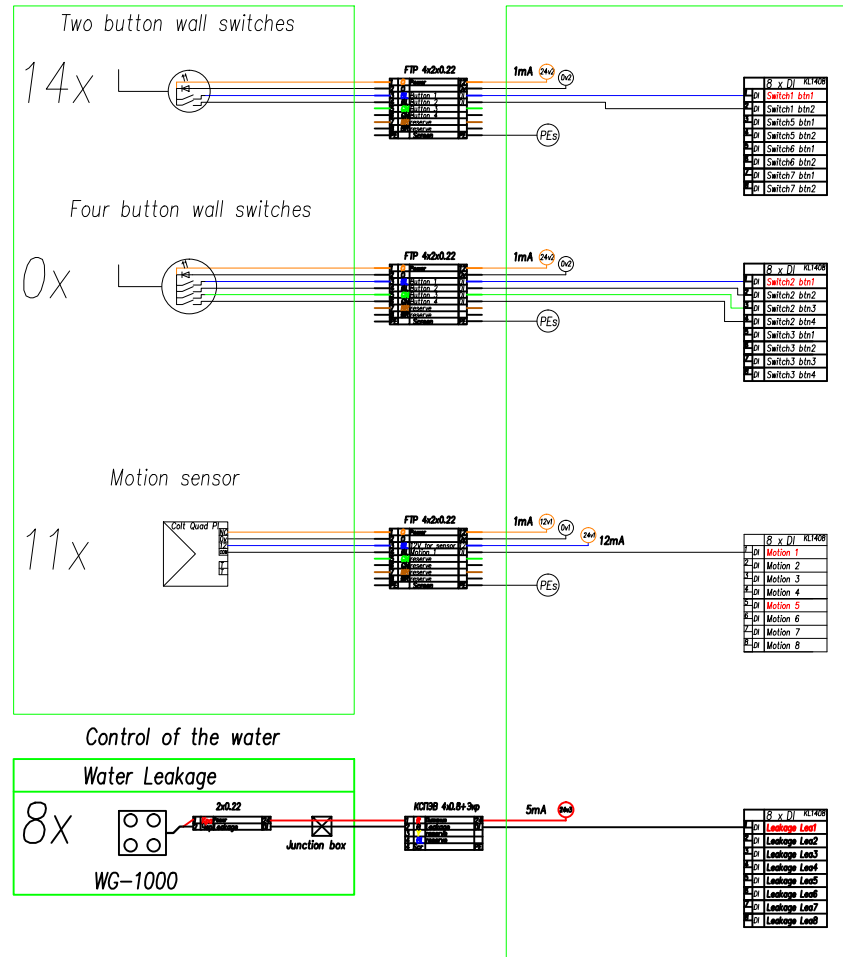
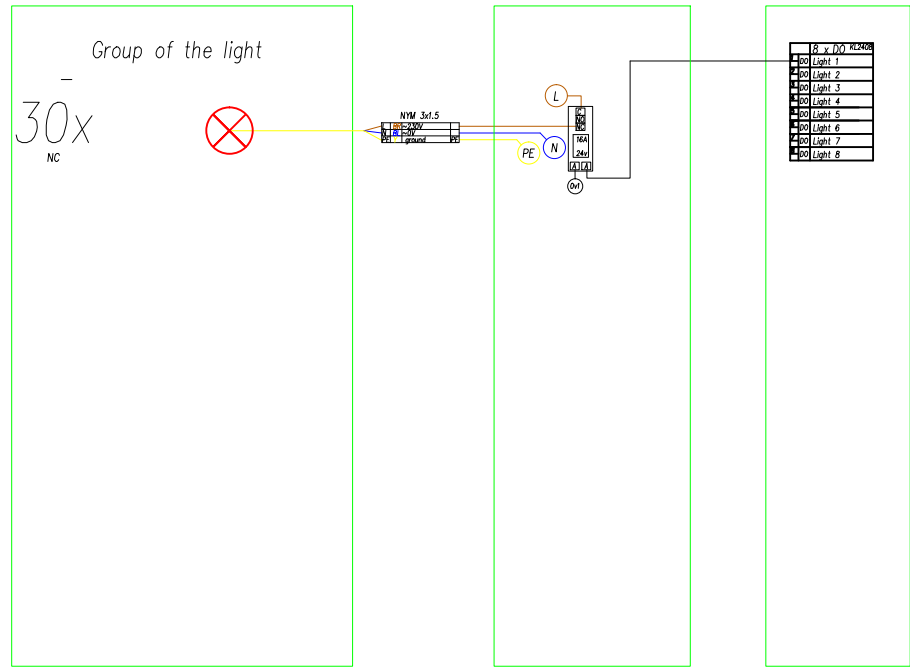


Conventional signs	Name	Unit	Number
	Circuit breaker ABB S201C16	pcs.	1
	Relay base ABB CR-PLSx	pcs.	32
	Relay base ABB CR-M	pcs.	0
	PSU 120W 24V/12V - battery	pcs.	1
	PSU 240W 24V/12V	pcs.	1
	Power converter 24v/12v	pcs.	1
	Controller Beckhoff CX9000	pcs.	1
	Module K-Bus Beckhoff KL1408	pcs.	6
	Module K-Bus Beckhoff KL3468	pcs.	3
	Module K-Bus Beckhoff KL2408	pcs.	7
	Module K-Bus Beckhoff KL3403	pcs.	0
	Module K-Bus Beckhoff KL9010	pcs.	1
	GSM modem MC55 (Siemens)	pcs.	1
	Storage battery 12V 1.2 A h	pcs.	2

[illegible]

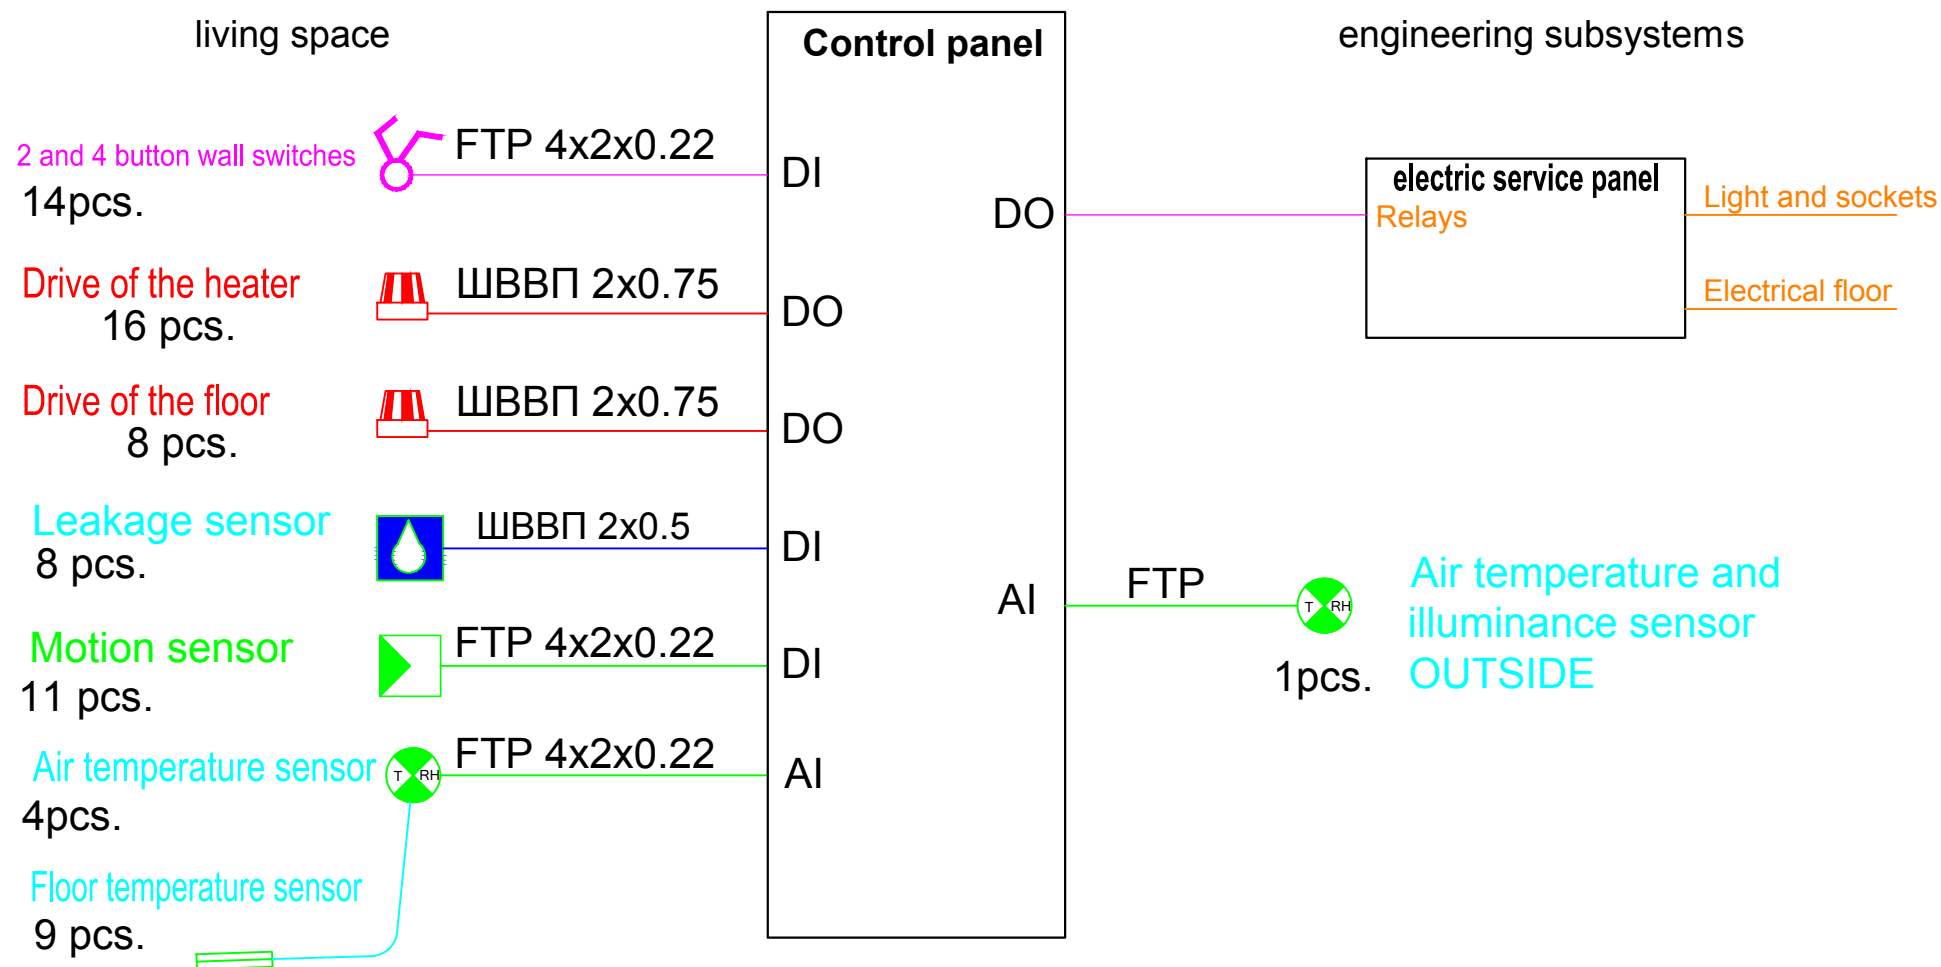


Изм.	Кол.	Лист	№ док.	Подпись	Дата			
						<i>A Cottage (example)</i>		
						Стадия	Лист	Листов
							3.1	2
						Wiring diagrams (paart 1)		

[illegible]

Изм.	Кол.	Лист	№ док.	Подпись	Дата			
						Стадия	Лист	Листов
							4	
						Connection schemes of the PLC		

Type diagram of the automatic control system

[illegible]